


N 48° 46' 10" E (p5)  
(p5&s)

(p5&s)

(p5&m)

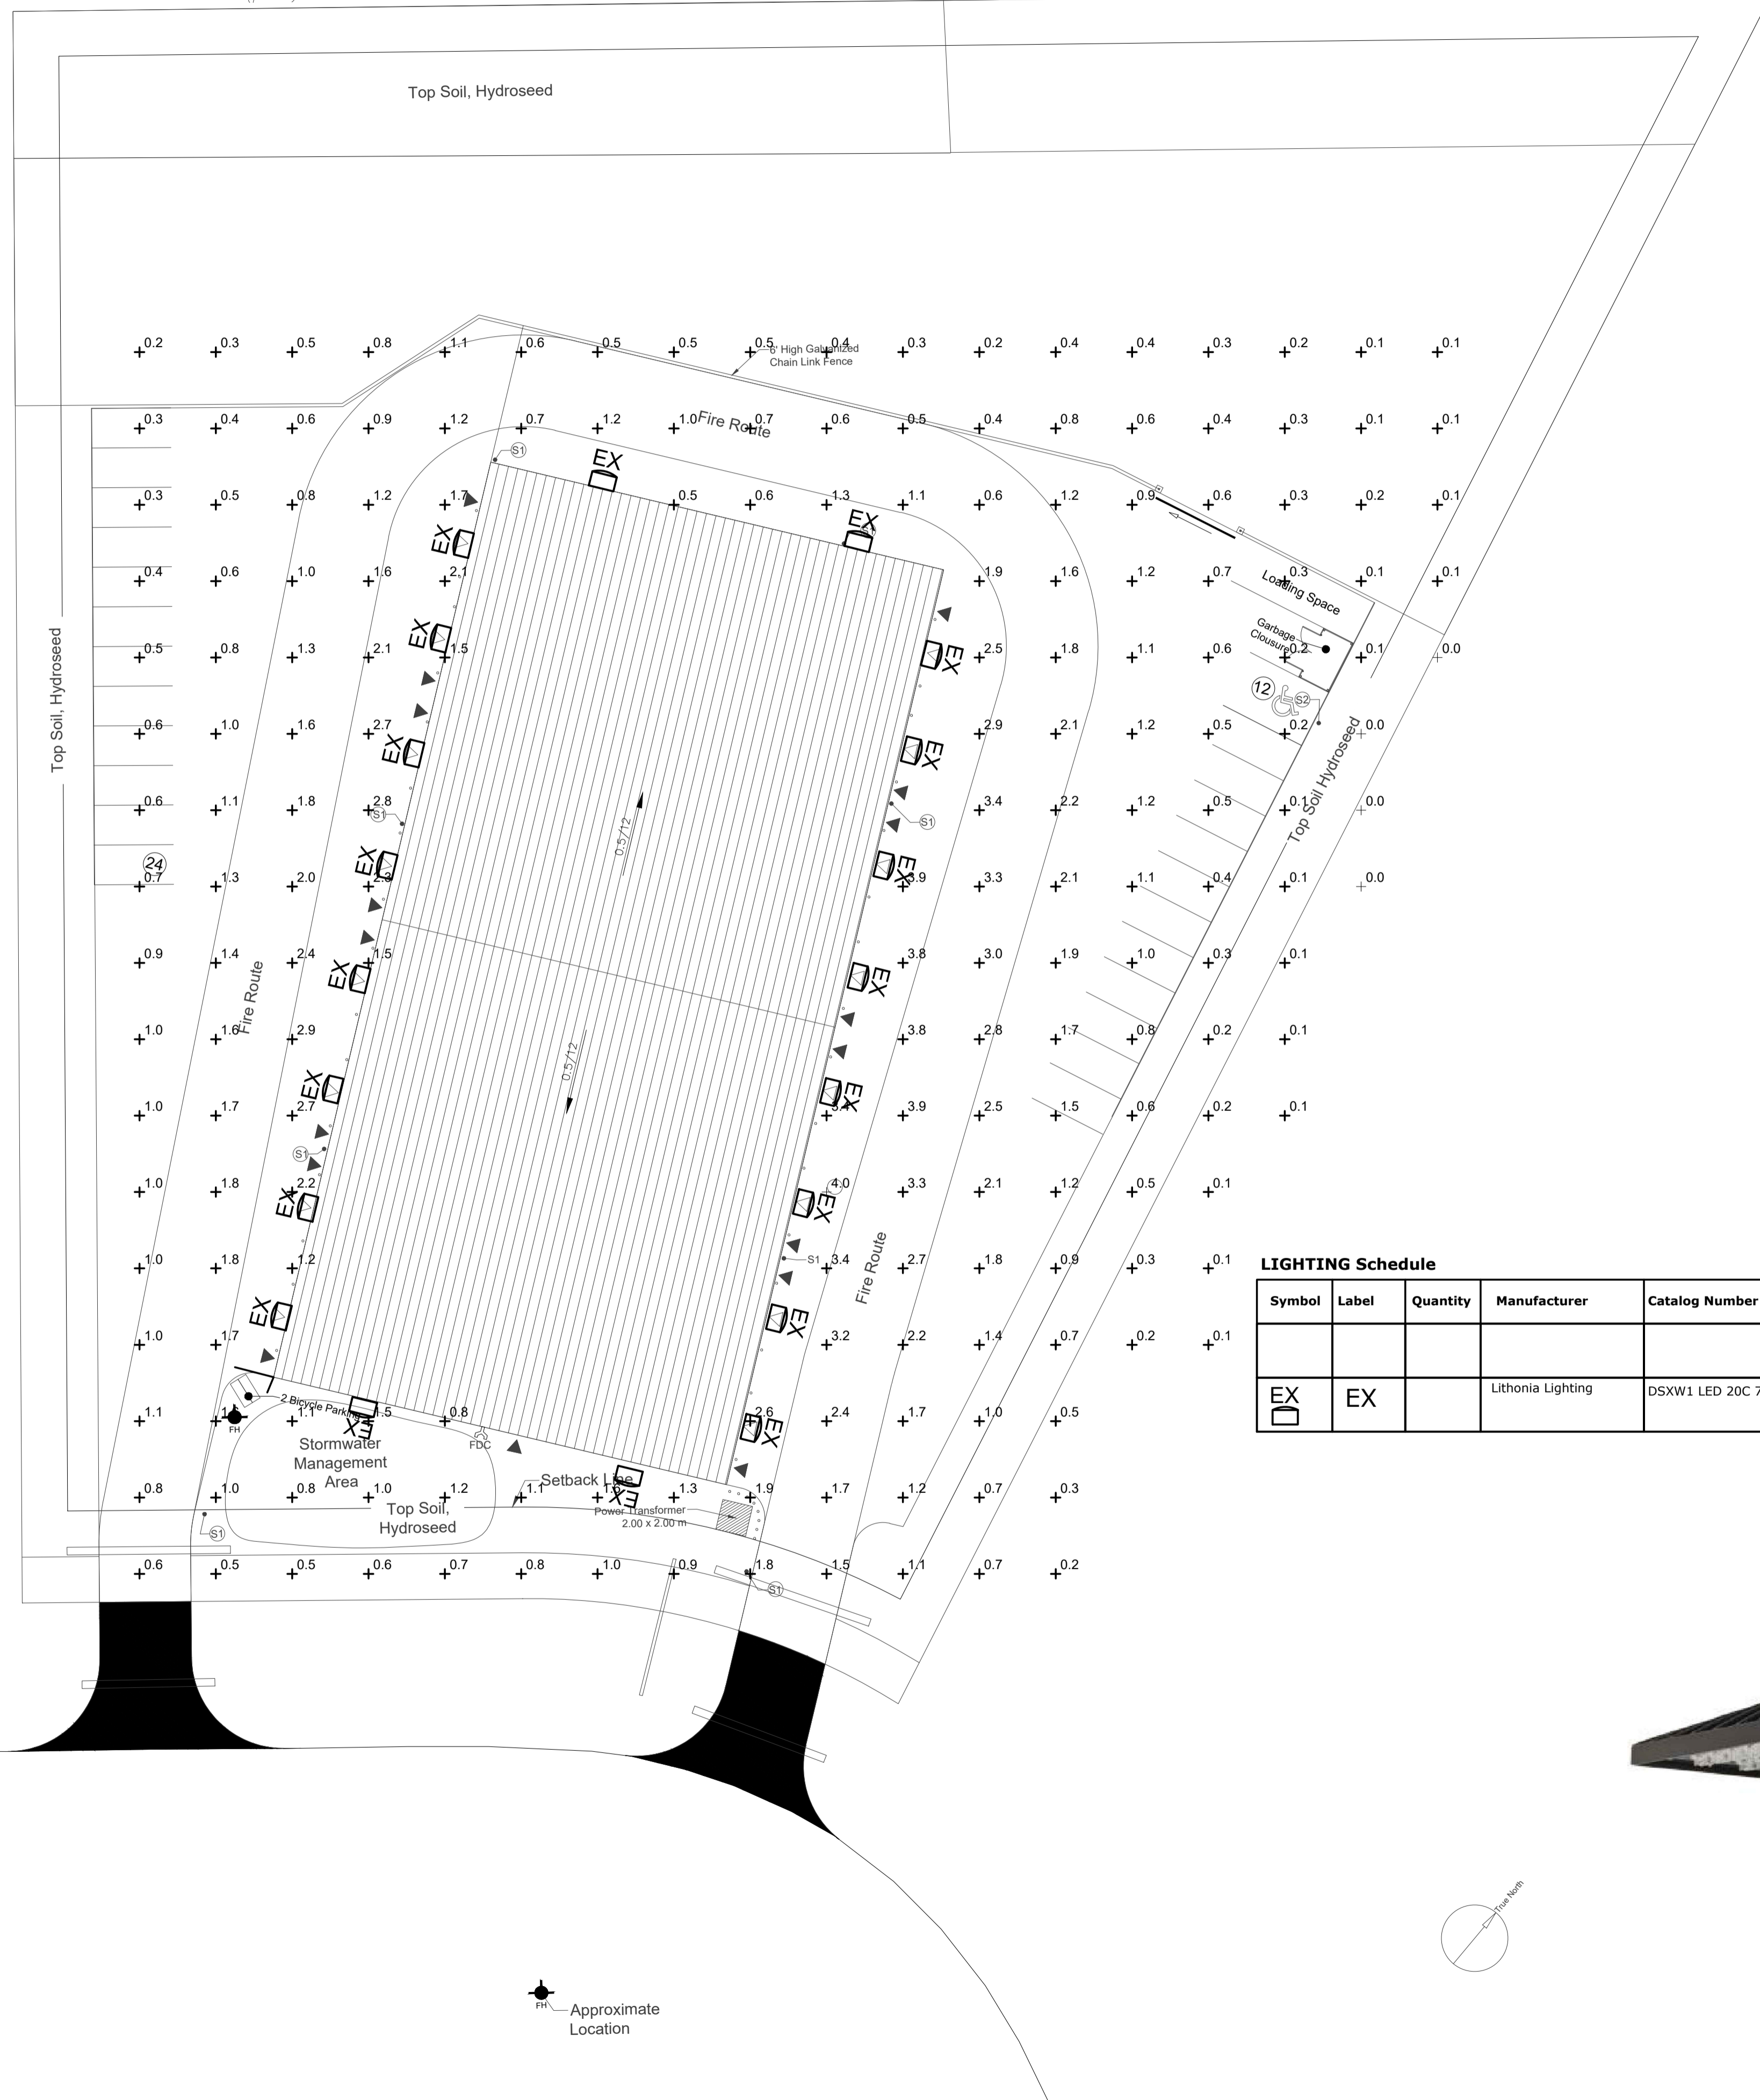

**LIGHTING Schedule**

Symbol	Label	Quantity	Manufacturer	Catalog Number	Description	Number Lamps	Lumens Per Lamp	Light Loss Factor	Wattage VOLTAGE
EX	EX		Lithonia Lighting	DSXW1 LED 20C 700 40K T3M		1	-	0.9	46 347V



REVISIONS		
No.	DATE	DESCRIPTION
1	APRIL 27, 2024	Issued for Coordination
2		
3		
4		
5		
6		
7		
8		
9		
10		

It is the responsibility of the appropriate contractor to check and verify all dimensions on site and report all errors and / or omissions to the Architect.  
All contractors must comply with all pertinent codes and by-laws.  
Do not scale drawings.  
This drawing may not be used for construction until signed by KWC Architects Inc. and shall not be used without the Architect's consent.

north

architects seal

excellence by design  
www.miriton.com

**BUILDING A REPUTATION ON EXCELLENCE**

BBS CONSTRUCTION (ONTARIO) LTD.  
223 RUSS BRADLY ROAD, UNIT 1  
CARP, ON. K0A 1L0, CANADA  
TEL: (613) 226-8830  
FAX: (613) 226-7709  
www.bbsconstruction.ca

owner  
**BBS CONSTRUCTION**

project  
**ALMONTE STORAGE BLDG**

drawing title  
**SITE LIGHTING PLAN AND ILLUMINATION LEVELS**

project no.	drawing no.
scale	<b>E-S1</b>
drawn by <b>MYI</b>	
date <b>26 APRIL 2024</b>	